



1 Front Elevation - Outside
1 : 50

3 Side Section - Outside
1 : 50

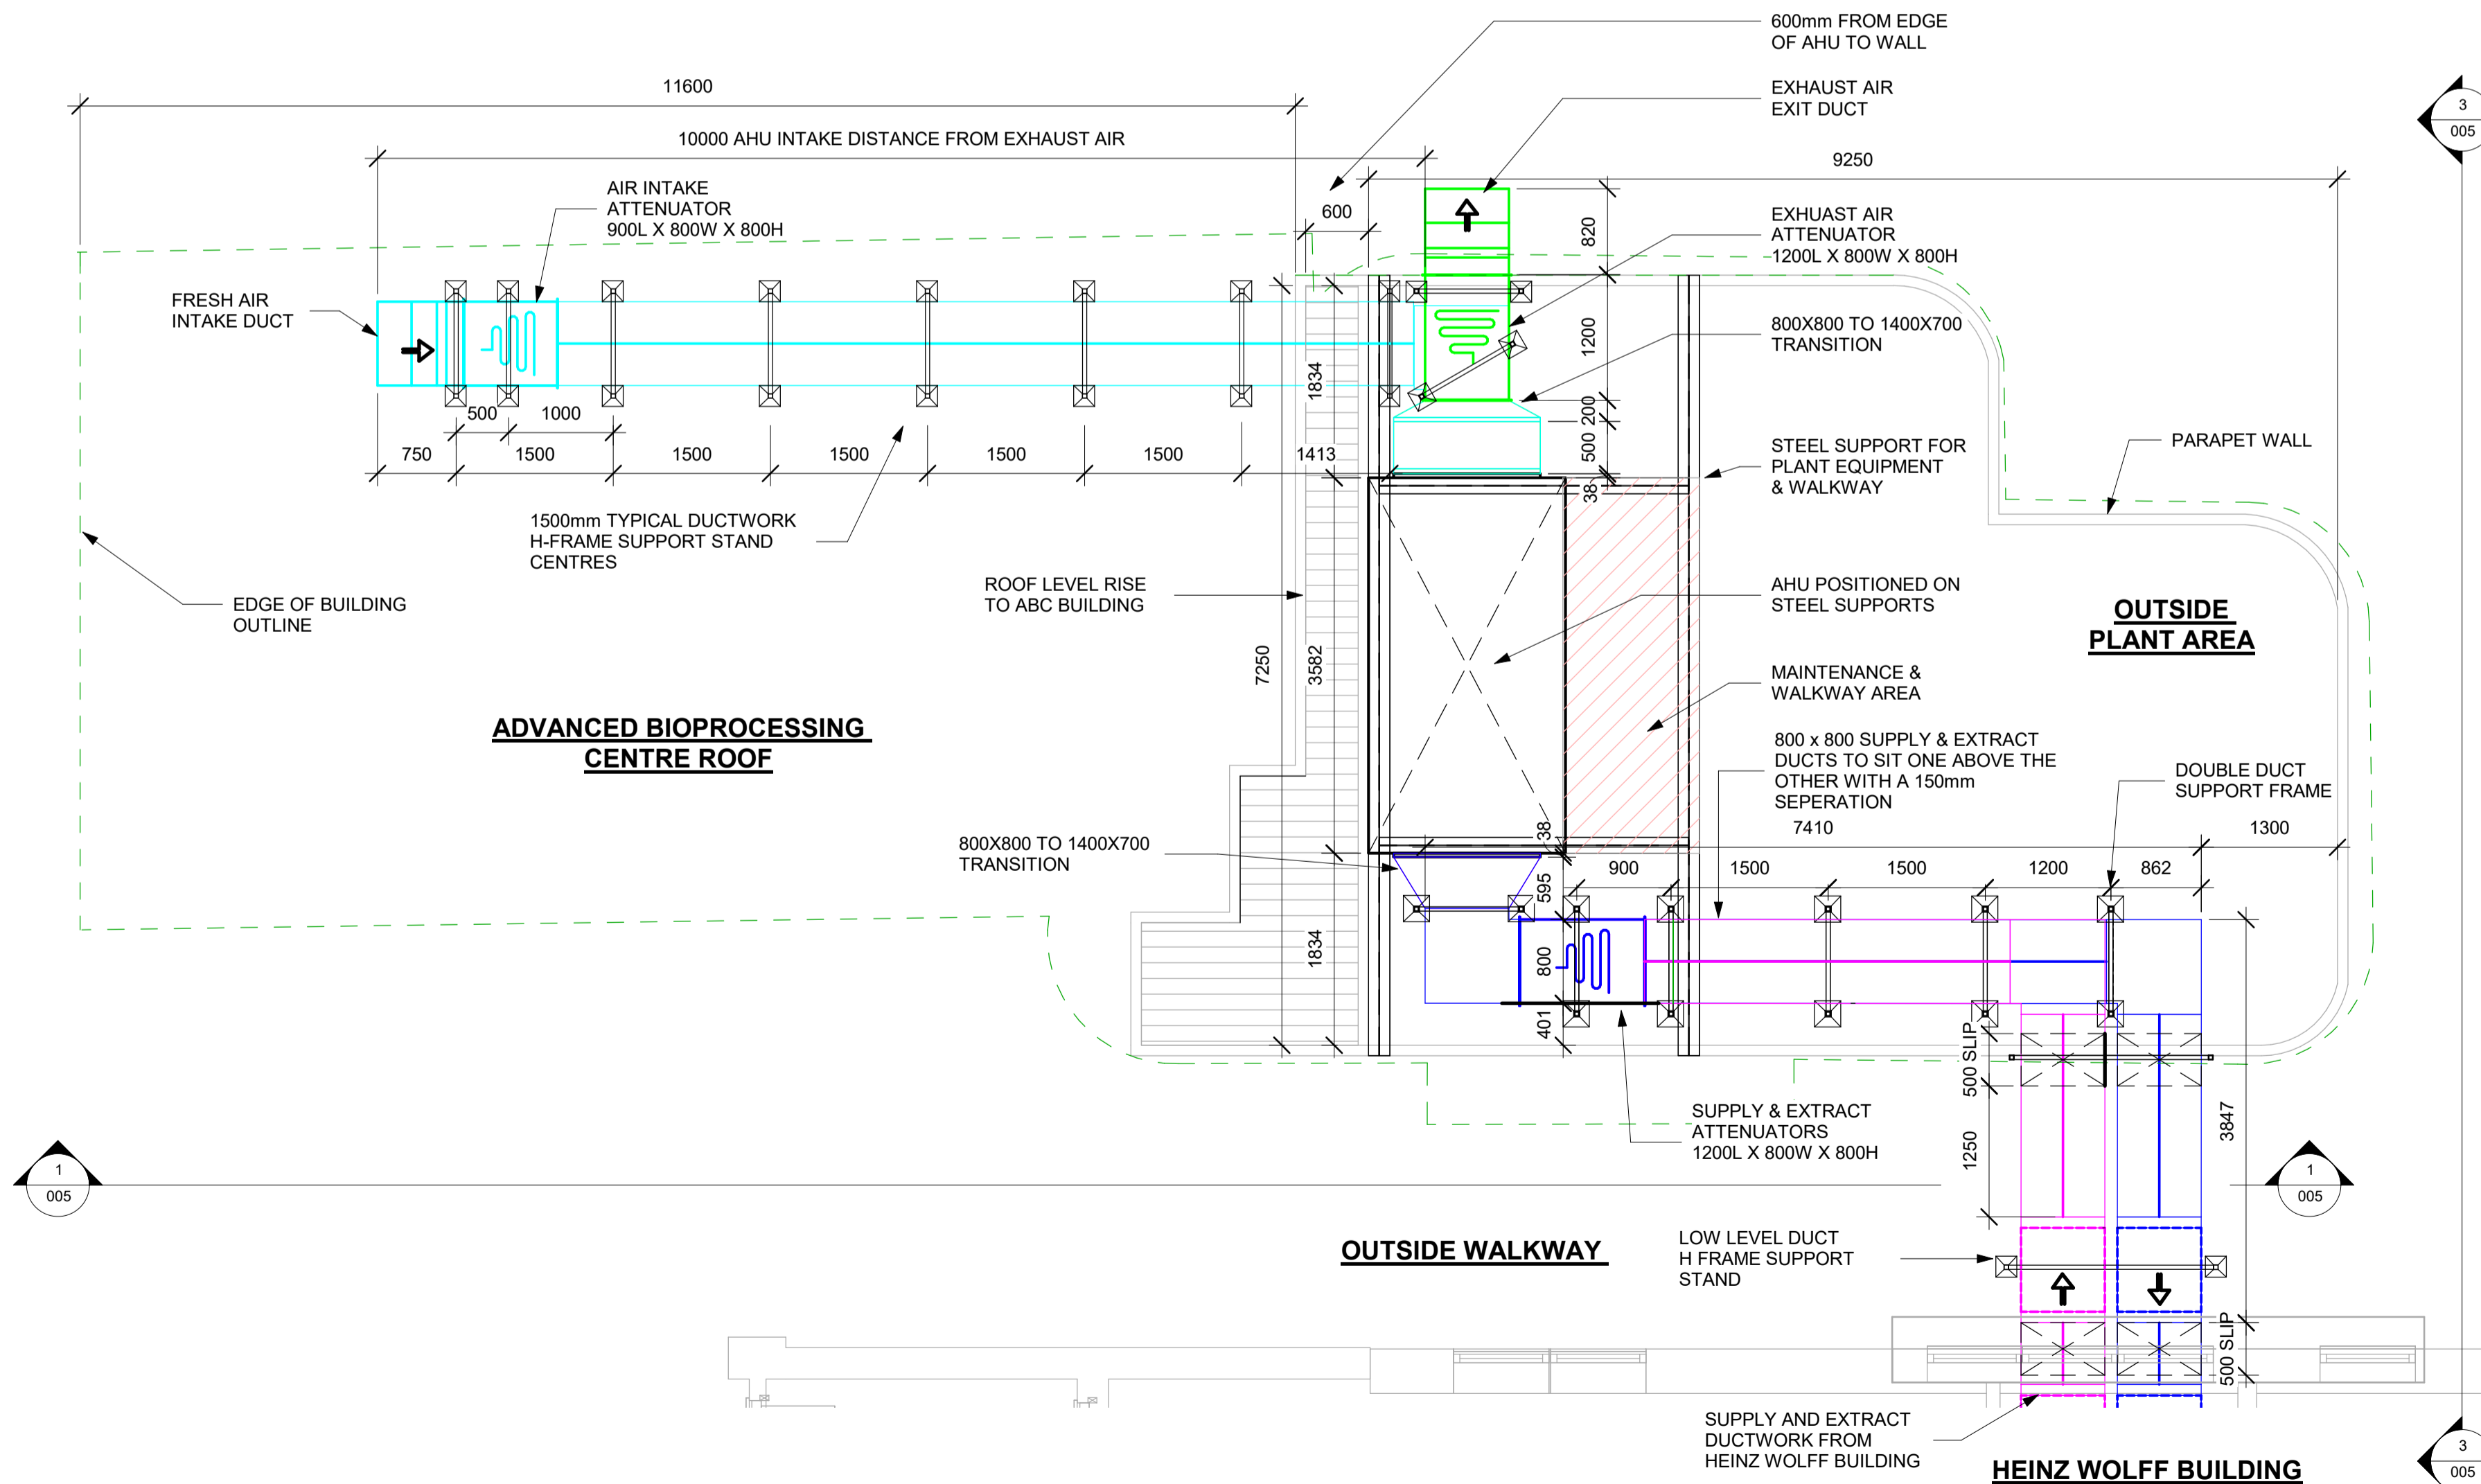

2 Outside Plant Area - Plan
1 : 50

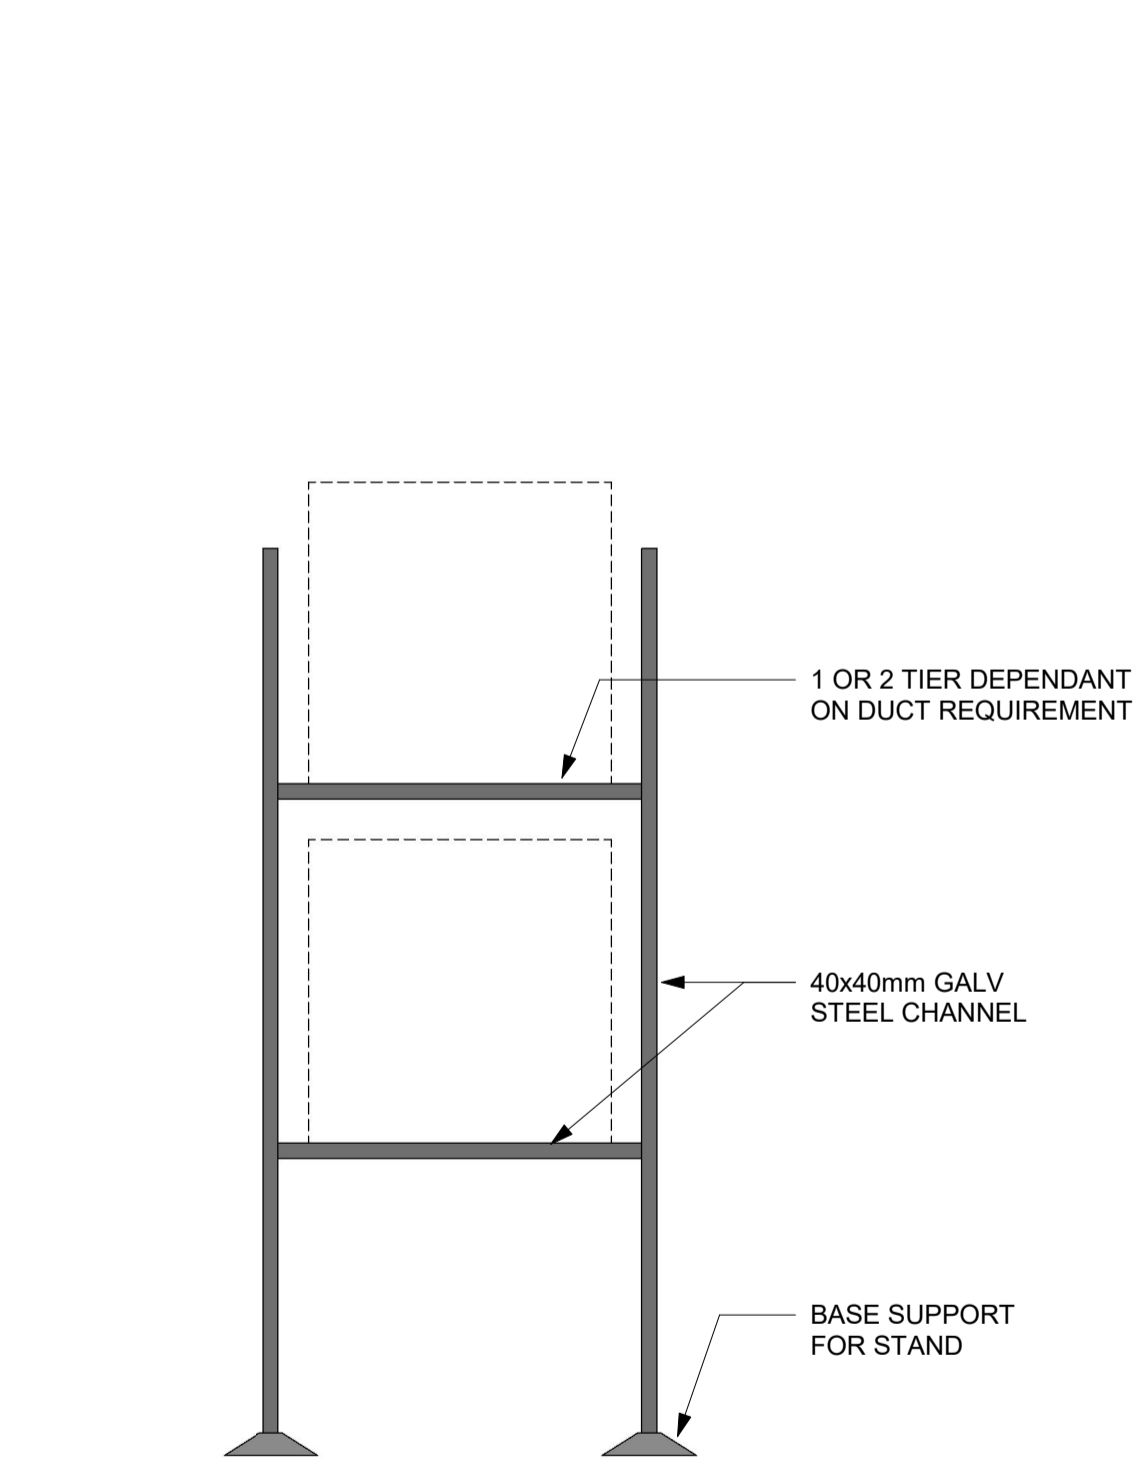

4 H-Frame Support Stand

REVISION	DATE	BY	DESCRIPTION
C	20.10.21	M.H.	FOR CONSTRUCTION
B	11.10.21	M.H.	AHU ADDED
A	04.10.21	M.H.	FIRST ISSUE

DRAWING STATUS:
CONSTRUCTION ISSUE

CLIENT:
HOLLYWELL BUILDING SERVICES

PROJECT:
HEINZ WOLFF BUILDING

DRAWING TITLE:
DUCTWORK LAYOUT OUTSIDE PLANT DECK

CONSTANT AIR SYSTEMS LTD
UNIT L, TURNPIKE WAY
CRESSSEX BUSINESS PARK, HIGH WYCOMBE
BUCKINGHAMSHIRE HP12 3TF
TELEPHONE: 01494 469529
FACSIMILE: 01494 469549
e-mail: admin@constantair.co.uk
HEATING, AIR CONDITIONING & MECHANICAL SERVICES ENGINEERS

SCALE: AS VIEW @ A1 WEBSITE: www.constantair.co.uk

DATE: 04.10.21 DRAWING NUMBER:

DRAWN BY: M.H. C71111-DW-005

CHECKED BY: K.K. A B C